


Jefferson Elementary School Addition and Remodel Jerome School District No. 261

600 N. Fillmore Street
Jerome, Idaho

24 February 2023
(Agency Review Set)




2400 E RIVERWALK DRIVE
BOISE, IDAHO 83706
WWW.LKVARCHITECTS.COM
208.336.3443

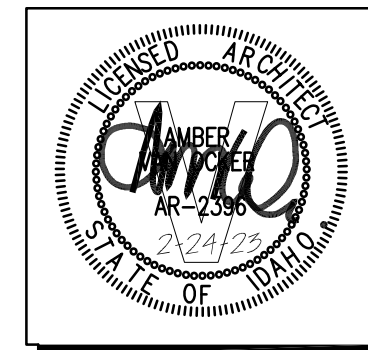

Project Team

OWNER	ARCHITECT	CONSTRUCTION MANAGER	CIVIL ENGINEER	LANDSCAPE ARCHITECT	STRUCTURAL ENGINEER	MECHANICAL ENGINEER	ELECTRICAL ENGINEER	INTERIOR DESIGNER
Jerome School District 125 4th Ave. West Jerome, Idaho 83338	LKV Architects 2400 East Riverwalk Dr. Boise, Idaho 83706	Starr Corporation 2996 E. 3600 N. Twin Falls, Idaho, 83303	Breckon Land Design, Inc. 6661 N. Glenwood St Boise, Idaho 83714	Breckon Land Design, Inc. 6661 N. Glenwood St Boise, Idaho 83714	Lochsa Engineering 201 N. Maple Grove Rd. Suite 100 Boise, Idaho 83704	Musgrove Engineering 234 S Whisperwood Way Boise, Idaho 83709	Musgrove Engineering 201 Parkway Dr. Boise, Idaho 83709	Weston Design Interiors 201 Parkway Dr. Boise, Idaho 83706
Name Primary Contact Phone: (208) ###-#### ###	Wayne Thowless Architect Phone: (208) 336-3443 Wayne@lkvarchitects.com	Jason Derrickott Project Manager Phone: (208) 733-5695 jason@starrcorporation.com	Jon Breckon Project Manager Phone: (208) 376-5153 jbreckon@breckonkd.com	Jon Breckon Project Manager Phone: (208) 376-5153 jbreckon@breckonkd.com	Chris Holladay Project Manager Phone: (208) 342-7168 cholladay@lochsaalidaho.com	Bill Carter Project Manager Phone: (208) 384-0585 billc@musgrovepa.com	Kurt Lechtenberg Interior Designer Phone: (208) 384-0585 kurtl@musgrovepa.com	Diane Weston Interior Designer Phone: (208) 343-7878 westondesign14@gmail.com

Vicinity Map

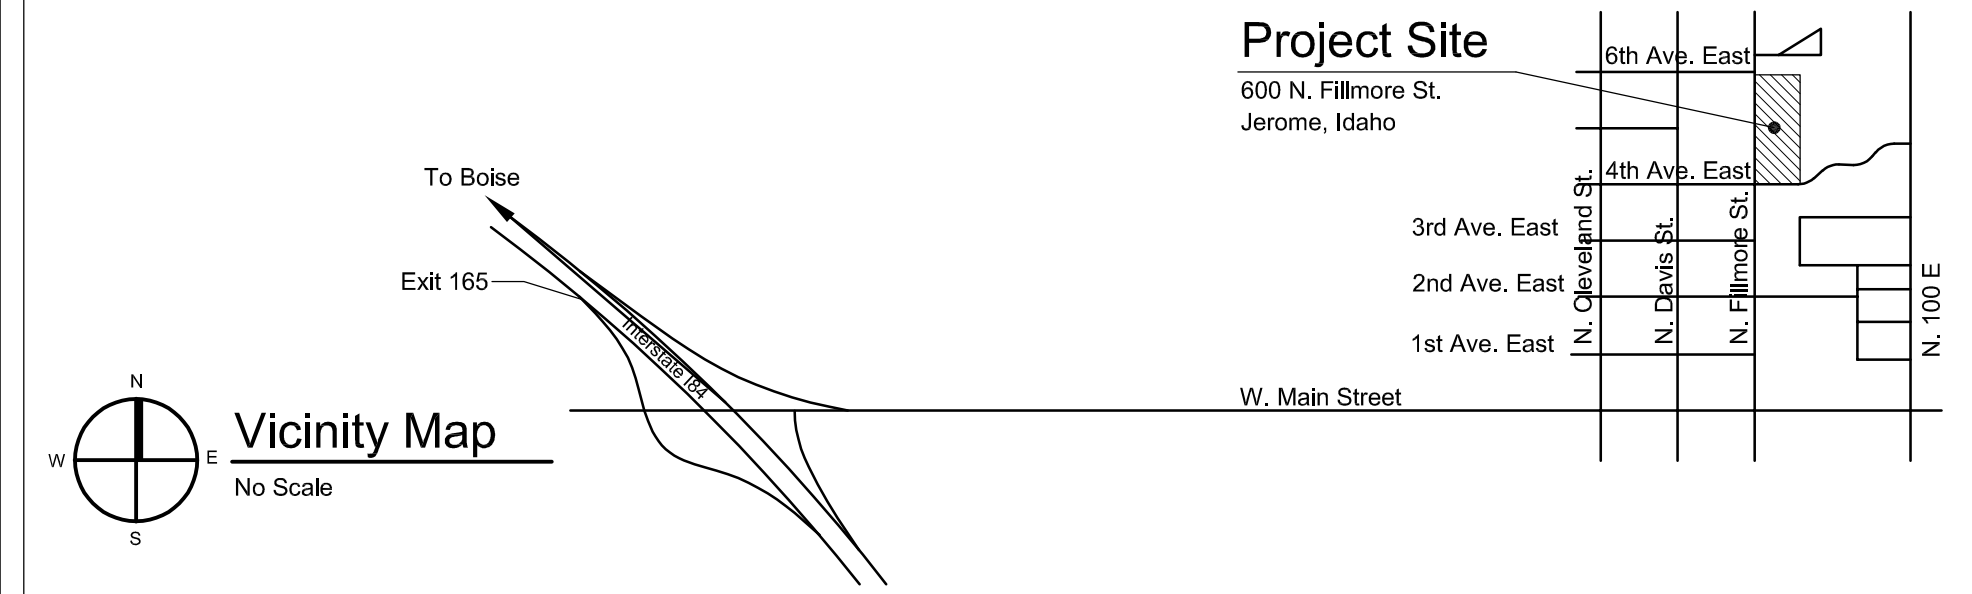

SET NO.

CONSTRUCTION SET

Building Data

SCOPE:	ELEMENTARY SCHOOL ADDITION AND REMODEL
OCCUPANCY GROUP:	GROUP E, EDUCATIONAL, S-1 ACCESSORY
EXISTING CONSTRUCTION:	CONCRETE FOOTINGS, STEM WALLS, AND FLOOR SLAB; WOOD STUD AND CMU EXTERIOR AND PERIMETER WALLS; WOOD STUD AND GYPSUM BOARD INTERIOR WALLS AND NON-BEARING PARTITIONS; PRE-ENGINEERED WOOD ROOF TRUSSES AND OPEN WEB STEEL JOISTS; WOOD AND STEEL ROOF DECKS WITH SINGLE PLY MEMBRANE ROOFING; NEW FIRE ALARM AND FIRE SPRINKLER SYSTEMS THROUGHOUT.
CONSTRUCTION TYPE:	TYPE V, B
STORIES / HEIGHT:	SINGLE STORY; 30'-4" TO TOP OF PARAPET (NEW ADDITION)
SQUARE FOOTAGE (GROSS):	EXISTING: 51,306 S.F., NEW: 12,008 S.F., TOTAL: 63,314 S.F.
OCCUPANT LOAD:	3,015

Sheet Schedule & Drawing Symbols

COVER SHEET	ARCHITECTURAL DRAWINGS (CONTINUED)	STRUCTURAL DRAWINGS (CONTINUED)	PLUMBING DRAWINGS (CONTINUED)
CIVIL & LANDSCAPE DRAWINGS	A-6.5 ROOF PLAN AREA 'D' & 'E'	S5.01 GENERAL CONCRETE DETAILS	P-1.5 PLUMBING DEMOLITION PLAN - AREA 'F'
SD0.1 SUMMARY PLAN	A-6.6 ROOF PLAN AREA 'F'	S5.02 GENERAL CONCRETE DETAILS	P-2.0 OVERALL PLUMBING NEW WORK FLOOR PLAN
SD0.2 SITE SURVEY	A-7.1 BUILDING SECTIONS	S5.03 GENERAL SLAB DETAILS	P-2.1 PLUMBING NEW WORK PLAN - AREA 'A'
SD0.10 OVERALL DEMOLITION PLAN	A-7.2 BUILDING SECTIONS	S5.11 GENERAL MASONRY DETAILS	P-2.2 PLUMBING NEW WORK PLAN - AREA 'B'
SD0.11 DEMOLITION PLAN - AREA ONE	A-7.3 BUILDING SECTIONS	S5.21 GENERAL STRUCTURAL STEEL DETAILS	P-2.3 PLUMBING NEW WORK PLAN - AREA 'C'
SD0.12 DEMOLITION PLAN - AREA TWO	A-7.4 BUILDING SECTIONS	S5.41 GENERAL WOOD FRAMING DETAILS	P-2.4 PLUMBING NEW WORK PLAN - AREA 'D' & 'E'
SD0.13 DEMOLITION PLAN - BASE BID	A-7.5 BUILDING SECTIONS	S6.01 FOUNDATION DETAILS	P-2.5 PLUMBING NEW WORK PLAN - AREA 'F'
SC2.0 UTILITY PLAN	A-7.6 WALL SECTIONS	S6.02 FOUNDATION DETAILS	P-3.0 RISER DIAGRAMS
SC2.5 UTILITY DETAILS	A-7.7 WALL SECTIONS	S6.03 FOUNDATION DETAILS	P-4.0 PLUMBING DETAILS
SD0.10 OVERALL LAYOUT PLAN	A-7.8 WALL SECTIONS	S6.04 FOUNDATION DETAILS	P-4.1 PLUMBING DETAILS
SD0.11 LAYOUT PLAN - AREA ONE	A-7.9 WALL SECTIONS	S8.01 ROOF FRAMING DETAILS	P-5.0 PLUMBING SCHEDULES
SD0.12 LAYOUT PLAN - AREA TWO	A-7.10 WALL SECTIONS	S8.02 ROOF FRAMING DETAILS	P-5.1 PLUMBING SCHEDULES
SD0.13 LAYOUT PLAN - BASE BID	A-7.11 WALL SECTIONS	S8.03 ROOF FRAMING DETAILS	ELECTRICAL DRAWINGS
SD0.4 PLAYGROUND LAYOUT PLAN	A-7.12 WALL SECTIONS	M0.0 HVAC COVER SHEET	E-0.0 ELECTRICAL COVER SHEET
SD0.5 LAYOUT DETAILS	A-7.13 WALL SECTIONS	M-0.1 MECHANICAL COMPLIANCE	E-0.1 LIGHTING COMPLIANCE
SD0.6 LAYOUT DETAILS	A-7.14 WALL SECTIONS	M-0.2 FIRE PROTECTION CRITERIA PLAN	E-0.2 ELECTRICAL SITE PLAN
SD0.4 OVERALL MATERIALS, STRIPING, & SIGNAGE PLAN	A-7.15 WALL SECTIONS	M-1.0 OVERALL MECHANICAL DEMOLITION FLOOR PLAN	E-0.1 OVERALL ELECTRICAL FLOOR PLAN
SD4.1 MATERIALS, STRIPING, & SIGNAGE PLAN - AREA ONE	A-8.1 DOOR & WINDOW DETAILS	M-1.1 MECHANICAL DEMOLITION FLOOR PLAN - AREA 'A'	E-2.1 ELECTRICAL DEMOLITION FLOOR PLAN - AREA 'A'
SD4.2 MATERIALS, STRIPING, & SIGNAGE PLAN - AREA TWO	A-8.2 DOOR & WINDOW DETAILS	M-1.2 MECHANICAL DEMOLITION FLOOR PLAN - AREA 'B'	E-2.2 ELECTRICAL DEMOLITION FLOOR PLAN - AREA 'B'
SD4.5 MATERIALS, STRIPING, & SIGNAGE DETAILS	A-8.3 DOOR & WINDOW DETAILS	M-1.3 MECHANICAL DEMOLITION FLOOR PLAN - AREA 'C'	E-2.3 ELECTRICAL DEMOLITION FLOOR PLAN - AREA 'C'
SD0.5 OVERALL GRADING AND DRAINAGE PLAN	A-8.4 DOOR & WINDOW DETAILS	M-1.4 MECHANICAL DEMOLITION FLOOR PLAN - AREA 'D' & 'E'	E-2.4 ELECTRICAL DEMOLITION FLOOR PLAN - AREA 'D' & 'E'
SD0.5.1 GRADING AND DRAINAGE PLAN - AREA ONE	A-8.5 DOOR & WINDOW DETAILS	M-1.5 MECHANICAL DEMOLITION FLOOR PLAN - AREA 'F'	E-2.5 ELECTRICAL DEMOLITION FLOOR PLAN - AREA 'F'
SD0.5.2 GRADING AND DRAINAGE PLAN - AREA TWO	A-8.6 WALL DETAILS	M-2.0 OVERALL MECHANICAL NEW WORK FLOOR PLAN	E-2.6 OVERALL ELECTRICAL ROOF DEMOLITION PLAN
SD0.5.3 GRADING AND DRAINAGE DETAILS	A-8.7 WALL DETAILS	M-2.1 MECHANICAL NEW WORK PLAN - AREA 'A'	E-3.0 OVERALL FIRE ALARM FLOOR PLAN
SD0.6 EROSION AND SEDIMENT CONTROL PLAN	A-8.8 DETAILS	M-2.2 MECHANICAL NEW WORK PLAN - AREA 'B'	E-4.1 LIGHTING FLOOR PLAN - AREA 'A'
SD0.6.5 EROSION AND SEDIMENT CONTROL DETAILS	A-8.9 ROOF DETAILS	M-2.3 MECHANICAL NEW WORK PLAN - AREA 'B'	E-4.2 LIGHTING FLOOR PLAN - AREA 'B'
SL7.0 OVERALL IRRIGATION PLAN	A-8.10 ROOF DETAILS	M-2.4 MECHANICAL NEW WORK PLAN - AREA 'C'	E-4.3 LIGHTING FLOOR PLAN - AREA 'C'
SL7.5 IRRIGATION DETAILS	A-8.11 ROOF DETAILS	M-2.5 MECHANICAL NEW WORK PLAN - AREA 'D' & 'E'	E-4.4 LIGHTING FLOOR PLAN - AREA 'D' & 'E'
ARCHITECTURAL DRAWINGS	A-9.1 INTERIOR ELEVATIONS	M-3.0 OVERALL DEMOLITION MECHANICAL ROOF PLAN	E-4.5 LIGHTING FLOOR PLAN - AREA 'F'
A-1.1 CODE PLAN	A-9.2 INTERIOR ELEVATIONS	M-3.1 MECHANICAL DEMOLITION ROOF PLAN - AREA 'A'	E-5.1 MECHANICAL POWER FLOOR PLAN - AREA 'A'
A-1.2 ENERGY COMPLIANCE PLAN	A-9.3 INTERIOR ELEVATIONS	M-3.2 MECHANICAL DEMOLITION ROOF PLAN - AREA 'B'	E-5.2 MECHANICAL POWER FLOOR PLAN - AREA 'B'
A-1.3 MASTER KEYED NOTES	A-9.4 INTERIOR ELEVATIONS	M-3.3 MECHANICAL DEMOLITION ROOF PLAN - AREA 'C'	E-5.3 MECHANICAL POWER FLOOR PLAN - AREA 'C'
A-2.1 OVERALL DEMOLITION PLAN	A-10.1 MILLWORK	M-3.4 MECHANICAL DEMOLITION ROOF PLAN - AREA 'D' & 'E'	E-5.4 MECHANICAL POWER FLOOR PLAN - AREA 'D' & 'E'
A-2.2 DEMOLITION PLAN AREA 'A'	A-10.2 MILLWORK	M-3.5 MECHANICAL DEMOLITION ROOF PLAN - AREA 'F'	E-5.5 MECHANICAL POWER FLOOR PLAN - AREA 'F'
A-2.3 DEMOLITION PLAN AREA 'B'	A-11.1 OVERALL REFLECTED CEILING PLAN	M-4.0 OVERALL MECHANICAL NEW WORK ROOF PLAN	E-6.1 POWER FLOOR PLAN - AREA 'A'
A-2.4 DEMOLITION PLAN AREA 'C'	A-11.2 REFLECTED CEILING PLAN AREA 'A'	M-4.1 MECHANICAL NEW WORK ROOF PLAN - AREA 'A'	E-6.2 POWER FLOOR PLAN - AREA 'B'
A-2.5 DEMOLITION PLAN AREA 'D' & 'E'	A-11.3 REFLECTED CEILING PLAN AREA 'B'	M-4.2 MECHANICAL NEW WORK ROOF PLAN - AREA 'B'	E-6.3 POWER FLOOR PLAN - AREA 'C'
A-2.6 DEMOLITION PLAN AREA 'F'	A-11.4 REFLECTED CEILING PLAN AREA 'C'	M-4.3 MECHANICAL NEW WORK ROOF PLAN - AREA 'C'	E-6.4 POWER FLOOR PLAN - AREA 'D' & 'E'
A-3.1 OVERALL FLOOR PLAN	A-11.5 REFLECTED CEILING PLAN AREA 'D' & 'E'	M-4.4 MECHANICAL NEW WORK ROOF PLAN - AREA 'D' & 'E'	E-6.5 POWER FLOOR PLAN - AREA 'F'
A-3.2 FLOOR PLAN AREA 'A'	A-11.6 REFLECTED CEILING PLAN AREA 'F'	M-4.5 MECHANICAL NEW WORK ROOF PLAN - AREA 'F'	E-6.6 ELECTRICAL ENLARGED KITCHEN PLAN - AREA 'B'
A-3.3 FLOOR PLAN AREA 'B'	STRUCTURAL DRAWINGS	M-5.0 HVAC DETAILS	E-7.1 SPECIAL SYSTEMS FLOOR PLAN - AREA 'A'
A-3.4 FLOOR PLAN AREA 'C'	S0.01 STRUCTURAL COVER SHEET	M-5.1 HVAC DETAILS	E-7.2 SPECIAL SYSTEMS FLOOR PLAN - AREA 'B'
A-3.5 FLOOR PLAN AREA 'D' & 'E'	S0.02 STRUCTURAL DESIGN NOTES	M-5.2 HVAC DETAILS	E-7.3 SPECIAL SYSTEMS FLOOR PLAN - AREA 'C'
A-3.6 FLOOR PLAN AREA 'F'	S0.03 STRUCTURAL DESIGN NOTES	M-6.0 HVAC SCHEDULE	E-7.4 SPECIAL SYSTEMS FLOOR PLAN - AREA 'D' & 'E'
A-3.7 ENLARGED KITCHEN FLOOR PLAN	S0.04 STRUCTURAL DESIGN NOTES	M-6.1 HVAC SCHEDULE	E-7.5 SPECIAL SYSTEMS FLOOR PLAN - AREA 'F'
A-3.8 ENLARGED FLOOR PLANS	S0.05 SPECIAL INSPECTION TABLES	M-6.2 HVAC SCHEDULE	E-8.1 ELECTRICAL ROOF PLAN - AREA 'A'
A-3.9 ENLARGED FLOOR PLANS	S1.00 OVERALL FOUNDATION PLAN	M-7.0 DDC CONTROLS	E-8.2 ELECTRICAL ROOF PLAN - AREA 'B'
A-3.10 GYMNASIUM STRIPING PLAN	S1.11 AREA A FOUNDATION PLAN	M-7.1 DDC CONTROLS	E-8.3 ELECTRICAL ROOF PLAN - AREA 'C'
A-3.11 ENLARGED KITCHEN PLANS AND DETAILS	S1.12 AREA B FOUNDATION PLAN	M-7.2 DDC CONTROLS	E-8.4 ELECTRICAL ROOF PLAN - AREA 'D' & 'E'
A-4.1 ROOM FINISH SCHEDULE	S1.13 AREA C FOUNDATION PLAN	M-7.3 DDC CONTROLS	E-8.5 ELECTRICAL ROOF PLAN - AREA 'F'
A-4.2 ROOM FINISH SCHEDULE AND DOOR TYPES	S1.20 OVERALL ROOF FRAMING PLAN	PLUMBING DRAWINGS	E-9.0 ONE-LINE DIAGRAM
A-4.3 DOOR AND WINDOW FRAME TYPES	S1.21 AREA A ROOF FRAMING PLAN	P-1.0 OVERALL PLUMBING DEMOLITION FLOOR PLAN	E-9.1 ELECTRICAL DETAILS
A-5.1 EXTERIOR ELEVATIONS	S1.22 AREA B ROOF FRAMING PLAN	P-1.1 PLUMBING DEMOLITION PLAN - AREA 'A'	E-10.0 ELECTRICAL SCHEDULES
A-5.2 EXTERIOR ELEVATIONS	S1.23 AREA C ROOF FRAMING PLAN	P-1.2 PLUMBING DEMOLITION PLAN - AREA 'B'	E-10.1 ELECTRICAL SCHEDULES
A-6.1 OVERALL ROOF PLAN	S1.24 AREA D AND E ROOF FRAMING PLAN	P-1.3 PLUMBING DEMOLITION PLAN - AREA 'C'	E-10.2 ELECTRICAL SCHEDULES
A-6.2 ROOF PLAN AREA 'A'	S1.25 AREA F ROOF FRAMING PLAN	P-1.4 PLUMBING DEMOLITION PLAN - AREA 'D' & 'E'	
A-6.3 ROOF PLAN AREA 'B'	S4.01 SCHEDULES		
A-6.4 ROOF PLAN AREA 'C'	S4.02 SCHEDULES - MASONRY PILASTER / LITEL		

SYMBOLS

	GRID LINE (NUMBERS & LETTERS)		ROOM NAME AREA LETTER / ROOM NUMBER		DETAIL NUMBER DETAIL SHEET NUMBER		ACCESSORY (NUMBER)
	SECTION LETTER BUILDING SECTION SHEET NUMBER		REFERENCE NOTE (NUMBER)		ELEVATION NUMBER SHEET NUMBER		REVISION (NUMBER)
	SECTION NUMBER WALL SECTION SHEET NUMBER		DOOR (NUMBER) SEE DOOR SCHEDULE		VIEW IDENTIFICATION		PARTITION TYPE (LETTER/NUMBER)
	SPECIFICATION KEYED NOTE SPEC. SECTION / ITEM DESIGNATION		WINDOW (LETTER) SEE WINDOW SCHEDULE		MATCH LINE NUMBER/LETTER		

Cover